


REFERENCE DRAWING	DWG. NO.
PIPING AND INSTRUMENTATION DIAGRAM SYMBOLS AND IDENTIFICATION FOR UREA PLANT	1208-01-PR-PID-051

NOTES:

- 1) PIPING LENGTH AND ELBOW NO. SHALL BE MINIMUM.

GENERAL NOTES:

- 1) FOR SYMBOLS AND OTHER DETAILS PLEASE REFER TO PID 1208-01-PR-PID-051 .
- 2) FOR THE DESCRIPTION OF ATTRIBUTES OF HYDRAULIC CONSTRAINTS OF LINES (SELF DRAINING, SLOPE, GRAVITY FLOW, ETC.) REFER TO DOC. "GENERAL REQUIREMENTS FOR PIPING" WHERE SPECIFIC REQUIREMENTS ARE INDICATED THAT PIPING SHALL FOLLOW.NO EXCEPTIONS ARE ALLOWED.

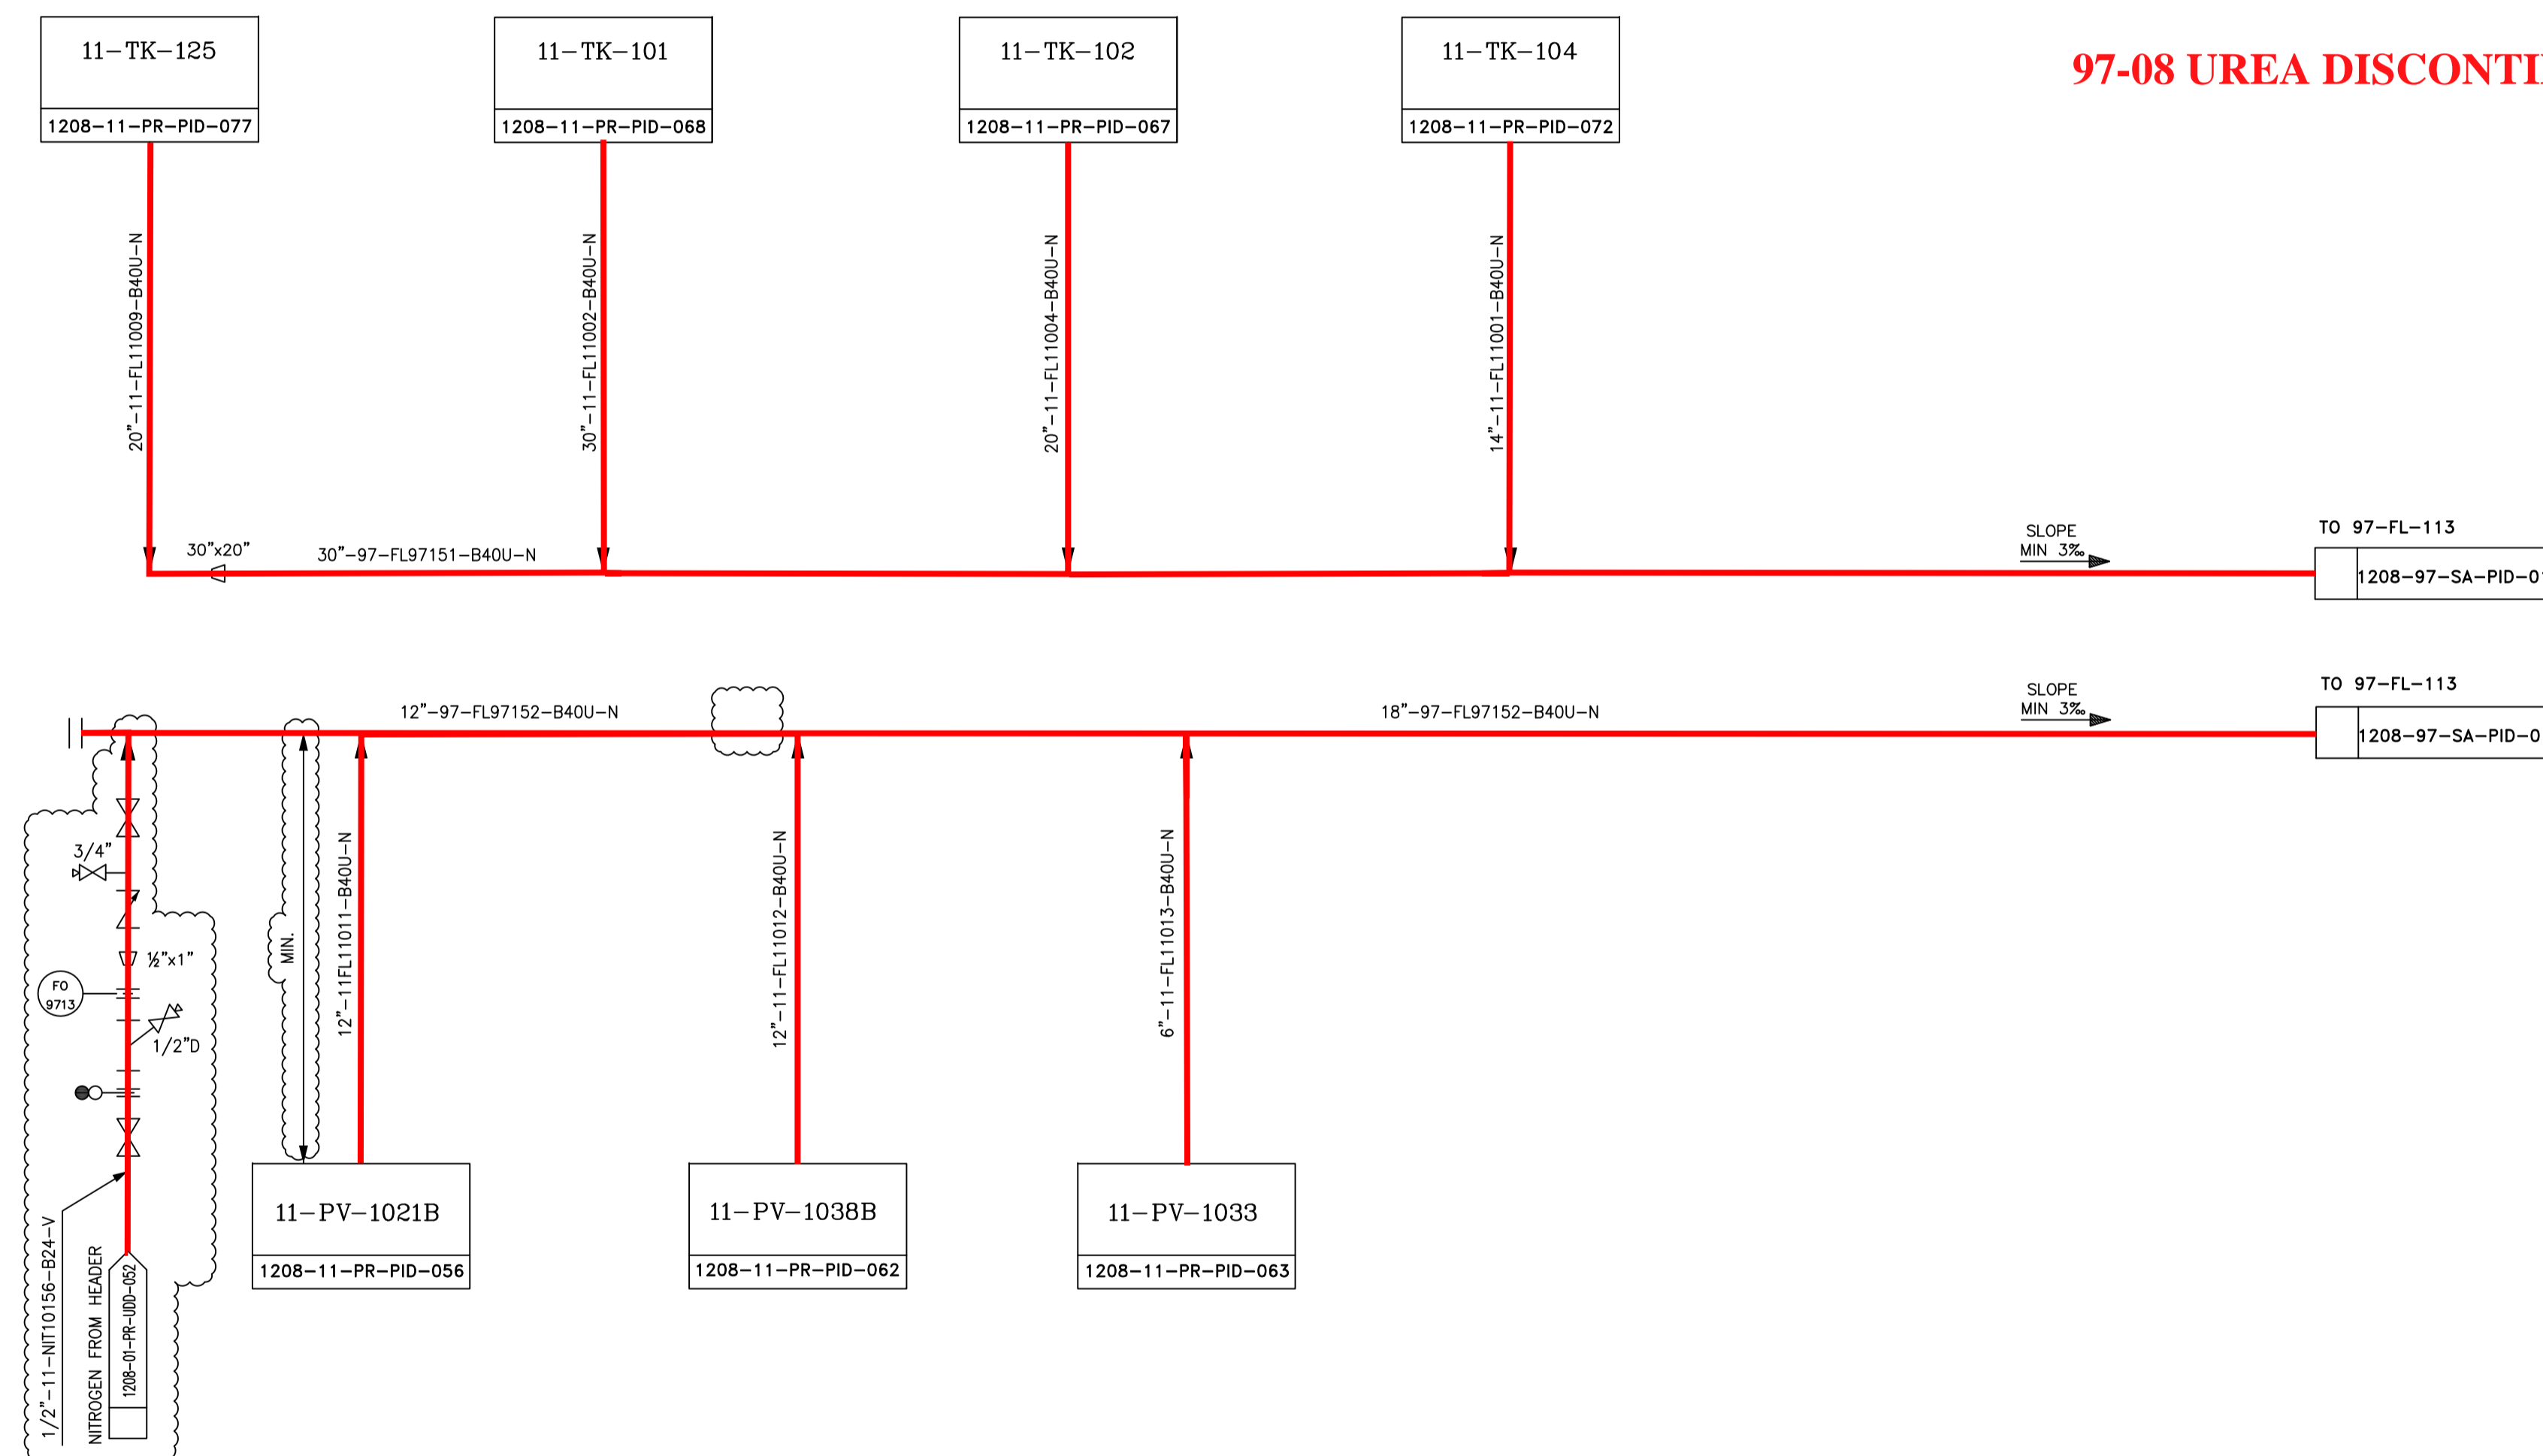

DE	EXT	AFC	A
Eng. Phase	Purpose of Distribution (POD)	Purpose of Issue (POI)	Owner's Action

REV.	ISSUE DATE	DESCRIPTION	PREPARED BY	CHECKED BY	APPROVED BY	PROJECT
03	10.03.2019	APPROVED FOR CONSTRUCTION	M.Setooni	M.Za	M.Za	M.Saremi
02	20.06.2018	ISSUED FOR ENGINEERING	M.Setooni	M.Za	M.Za	M.Saremi
01	26.04.2017	ISSUED FOR ENGINEERING	M.Kadiri	M.Zady	M.Za	M.Saremi
00	26.05.2013	ISSUED FOR ENGINEERING	M.Khademli	M.Za	M.Za	S.Foostapour

OWNER:

MC:

EPC CONTRACTOR:

PROJECT: HENGAM FERTILIZER PROJECT

TITLE: PIPING AND INSTRUMENTATION DIAGRAM
UREA VENT NETWORK

SCALE: N.T.S	OWNER PROJECT NO.: NA	DWG. NO.: 1208-97-SA-PID-014	REV: 03	SIZE: A1
SHT.: 1 OF 1	PIDEC PROJECT NO.: 1208			